

1

2

3

4

5

6



TESLA MOTORS, INC.

3500 DEER CREEK RD.
PALO ALTO, CA 94304


E

D

C

B

A

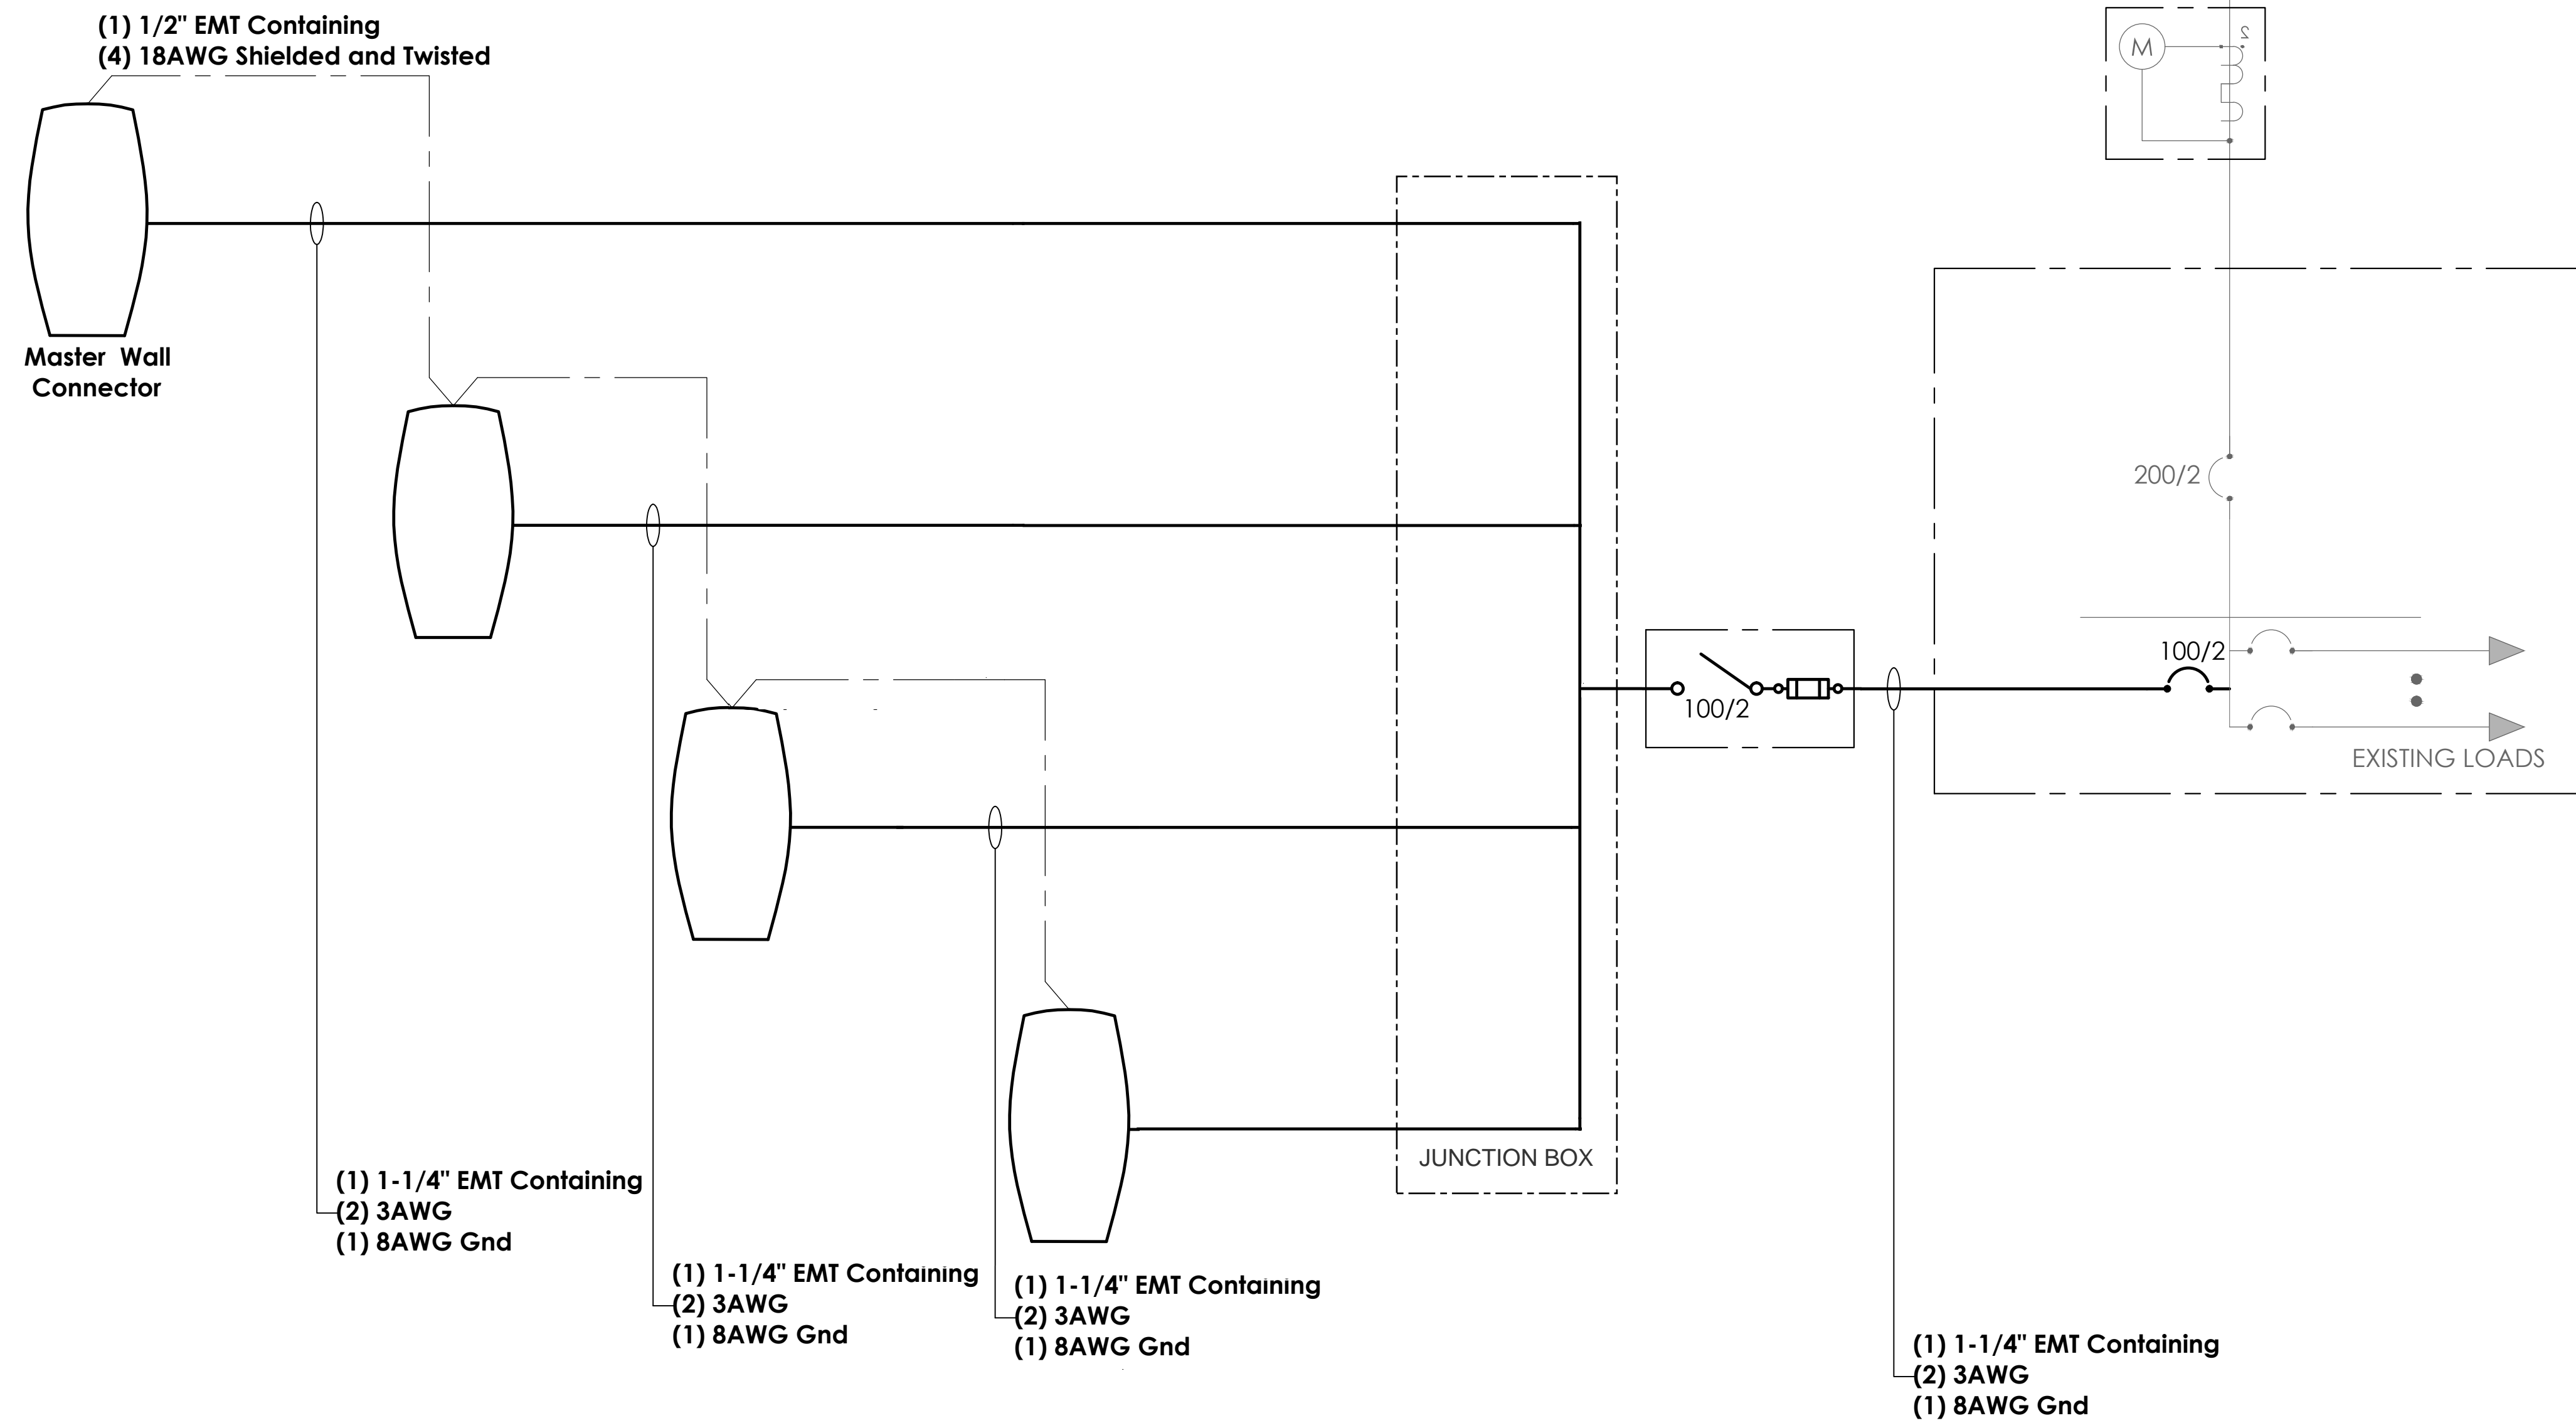

PRELIMINARY
NOT FOR
CONSTRUCTION

Single Line Diagram
Three Tesla Wall
Connectors

NO.	REVISION	DATE	INT.
1	Preliminary Draft	08.23.16	MA

ORIGINAL SIZE 24"X36"
SHEET SIZE ARCH "D"



SHEET TITLE
SLD

SHEET NUMBER
E0.01

A

Single Line Diagram

Scale: N/A